

REMOVAL KEY NOTES


R1	WALL SURFACE MOUNTED RACEWAY AND DEVICES IN ROOM B-168 TO BE DISCONNECTED, REMOVED. WIRE TO BE PULLED BACK TO SOURCE AND TAGGED FOR REUSE.
R2	TEMPORARILY SUPPORT SECURITY ESCORT RECEIVER BOX.
R3	DISCONNECT AND TAG EXISTING CIRCUITS FOR RE-USE.
R4	EXISTING DEVICE TO BE DISCONNECTED AND REMOVED, SA.
R5	DISCONNECT, REMOVE AND PULL WIRE BACK TO SOURCE. LABEL CIRCUIT AS SPARE.

RENOVATION KEY NOTES


1	PROVIDE CONDUIT AND WIRE, AND CIRCUIT TO PREVIOUSLY TAGGED CIRCUIT IN EXISTING PANEL. PROVIDE RECEPTACLES AND COVERPLATES AS DESIGNATED. INSTALL CONDUIT AND BOXES CONCEALED IN RENOVATED WALLS.
2	REINSTALL EXISTING SECURITY ESCORT RECEIVER BOX.

GENERAL NOTES:


- PROVIDE THROUGH AND MEMBER FIRESTOPPING AT ALL PENETRATIONS THROUGH FIRE RATED CONSTRUCTION. REFER TO ARCHITECTURAL PLANS FOR LOCATIONS OF FIRE RATED FLOOR, DECK, AND PARTITION TYPES INCLUDING RELEVANT UL DESIGN NUMBER AND FIRE RATED HOURS. REFER TO SPECIFICATION SECTION 078400 FOR ADDITIONAL FIRESTOPPING REQUIREMENTS.
- EXISTING WIREMOLD TO REMAIN UNLESS OTHERWISE NOTED.
- TEMPORARILY SUPPORT EXISTING CONDUIT PRIOR TO WALL REMOVAL. PROVIDE PERMANENT SUPPORT AFTER WALL IS INSTALLED.

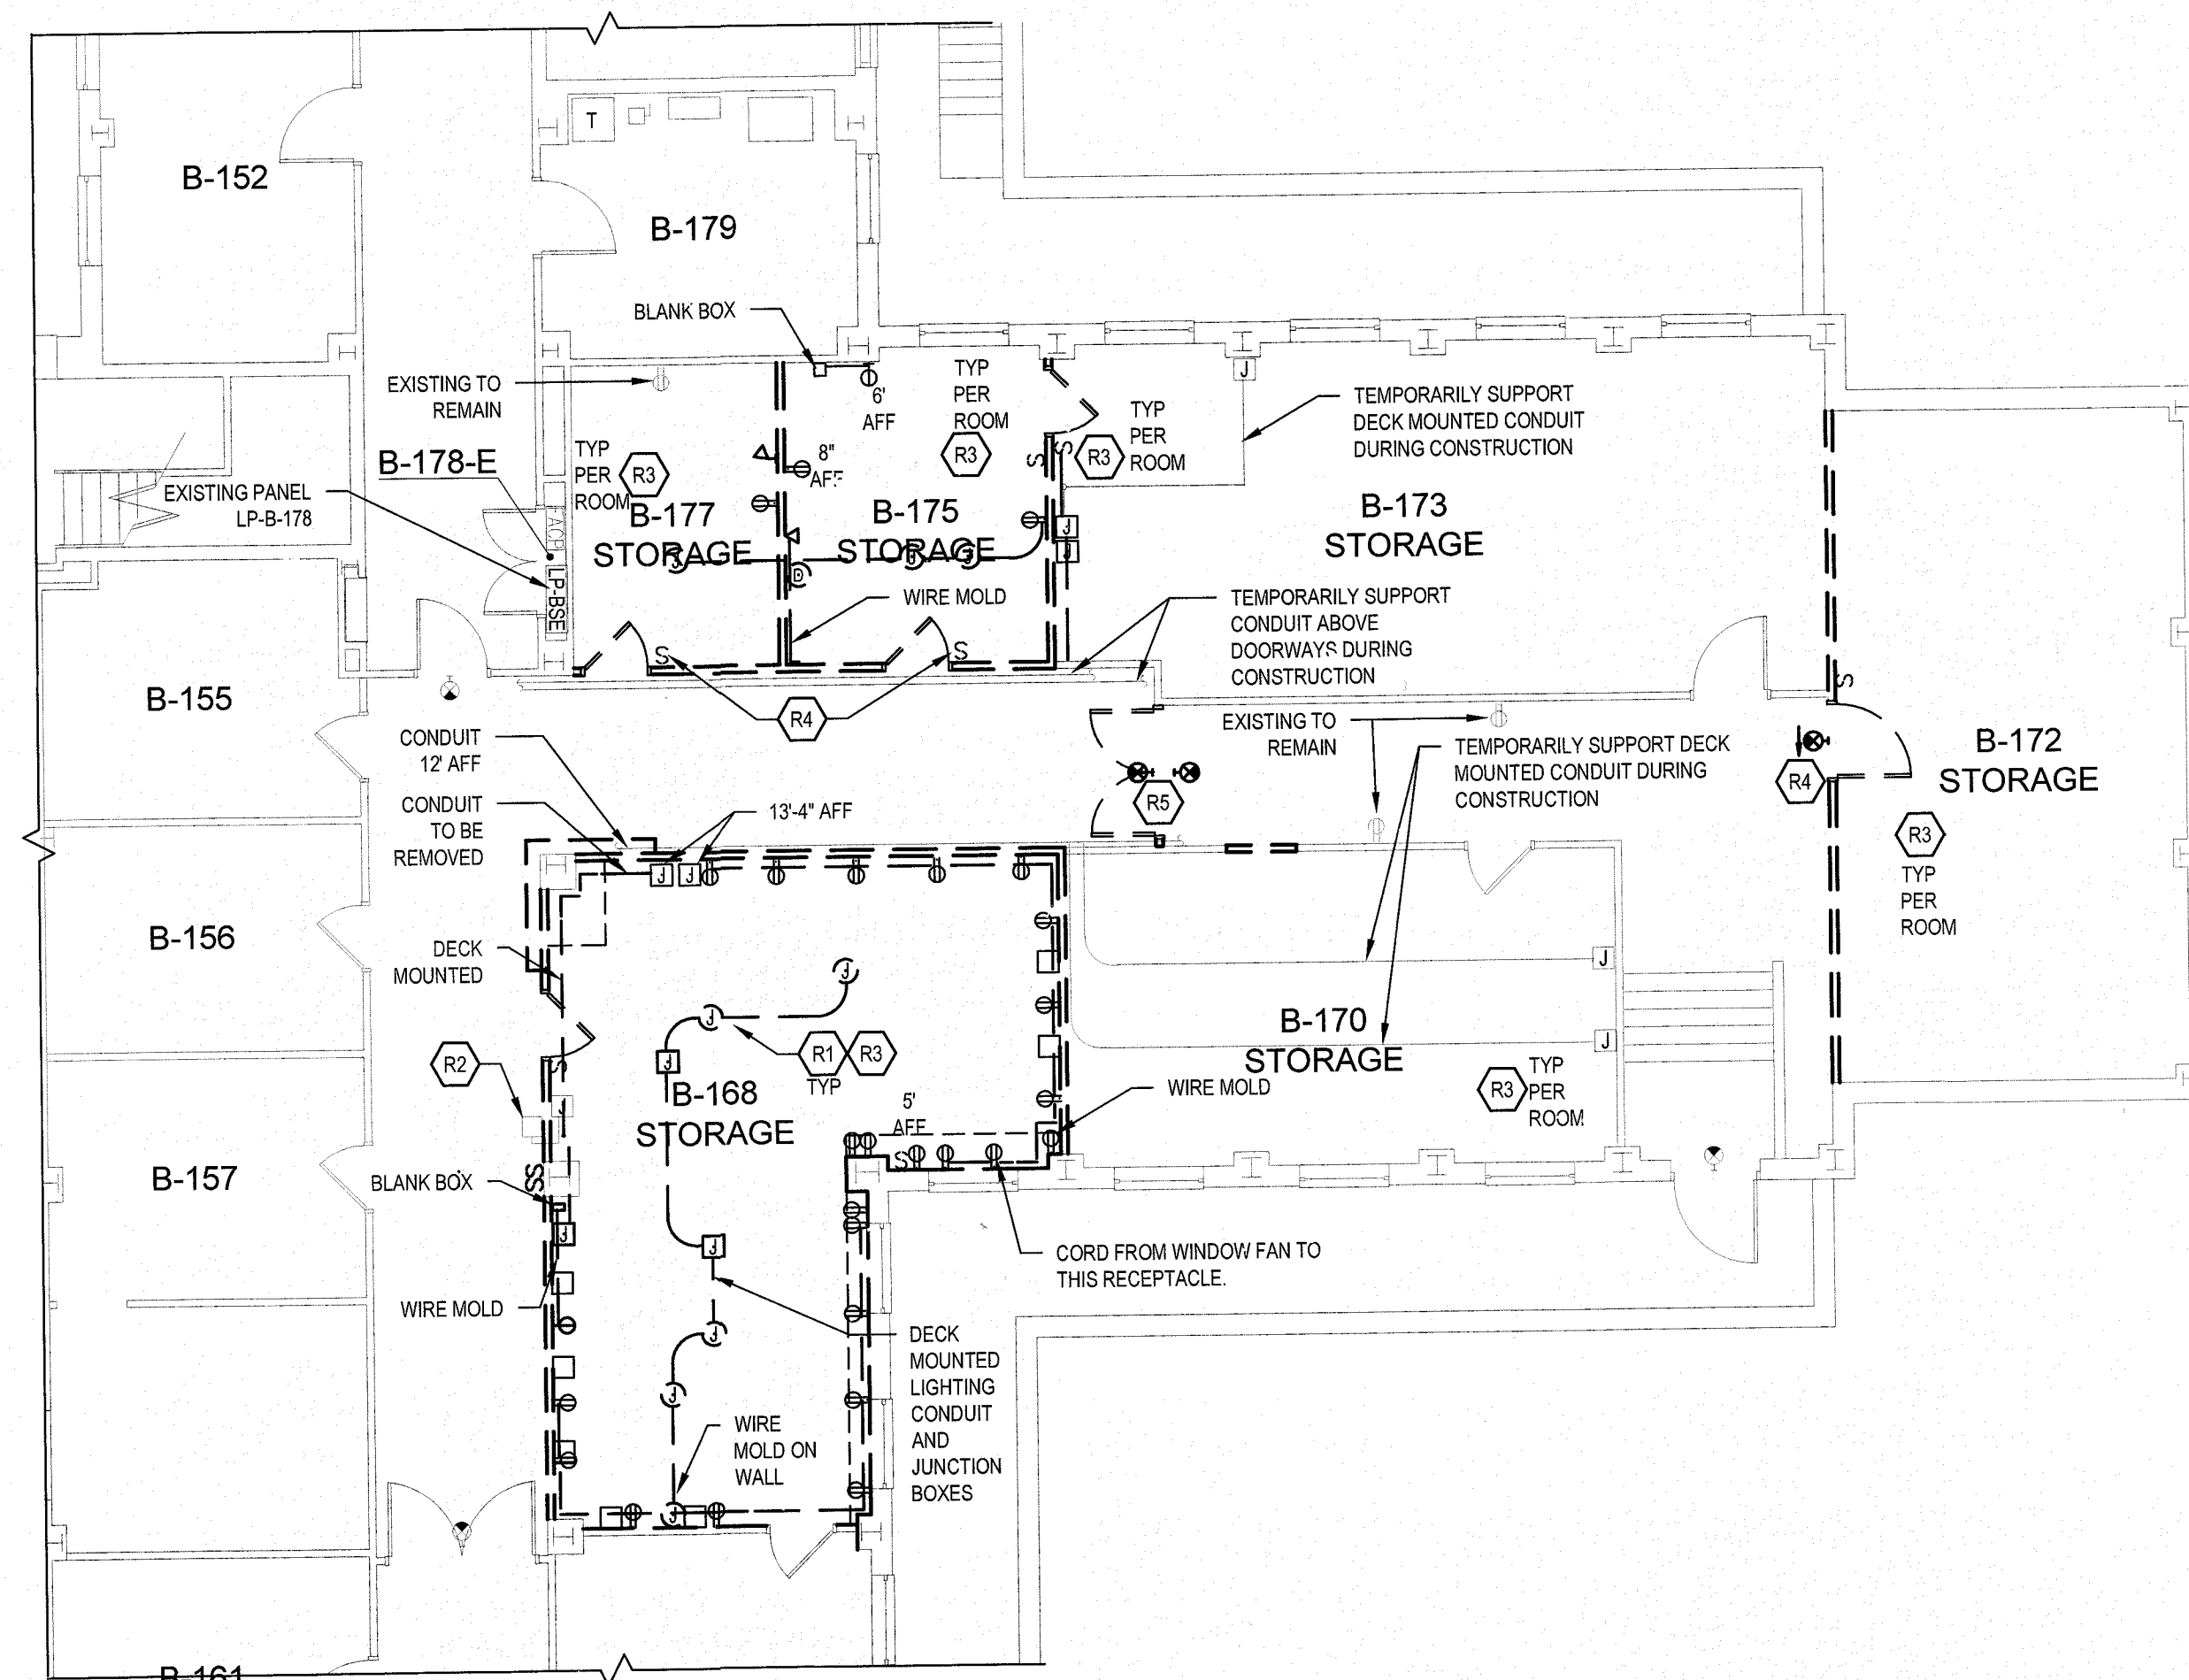

1 PARTIAL BASEMENT REMOVAL PLAN
E-101 SCALE: 1/8" = 1'-0"

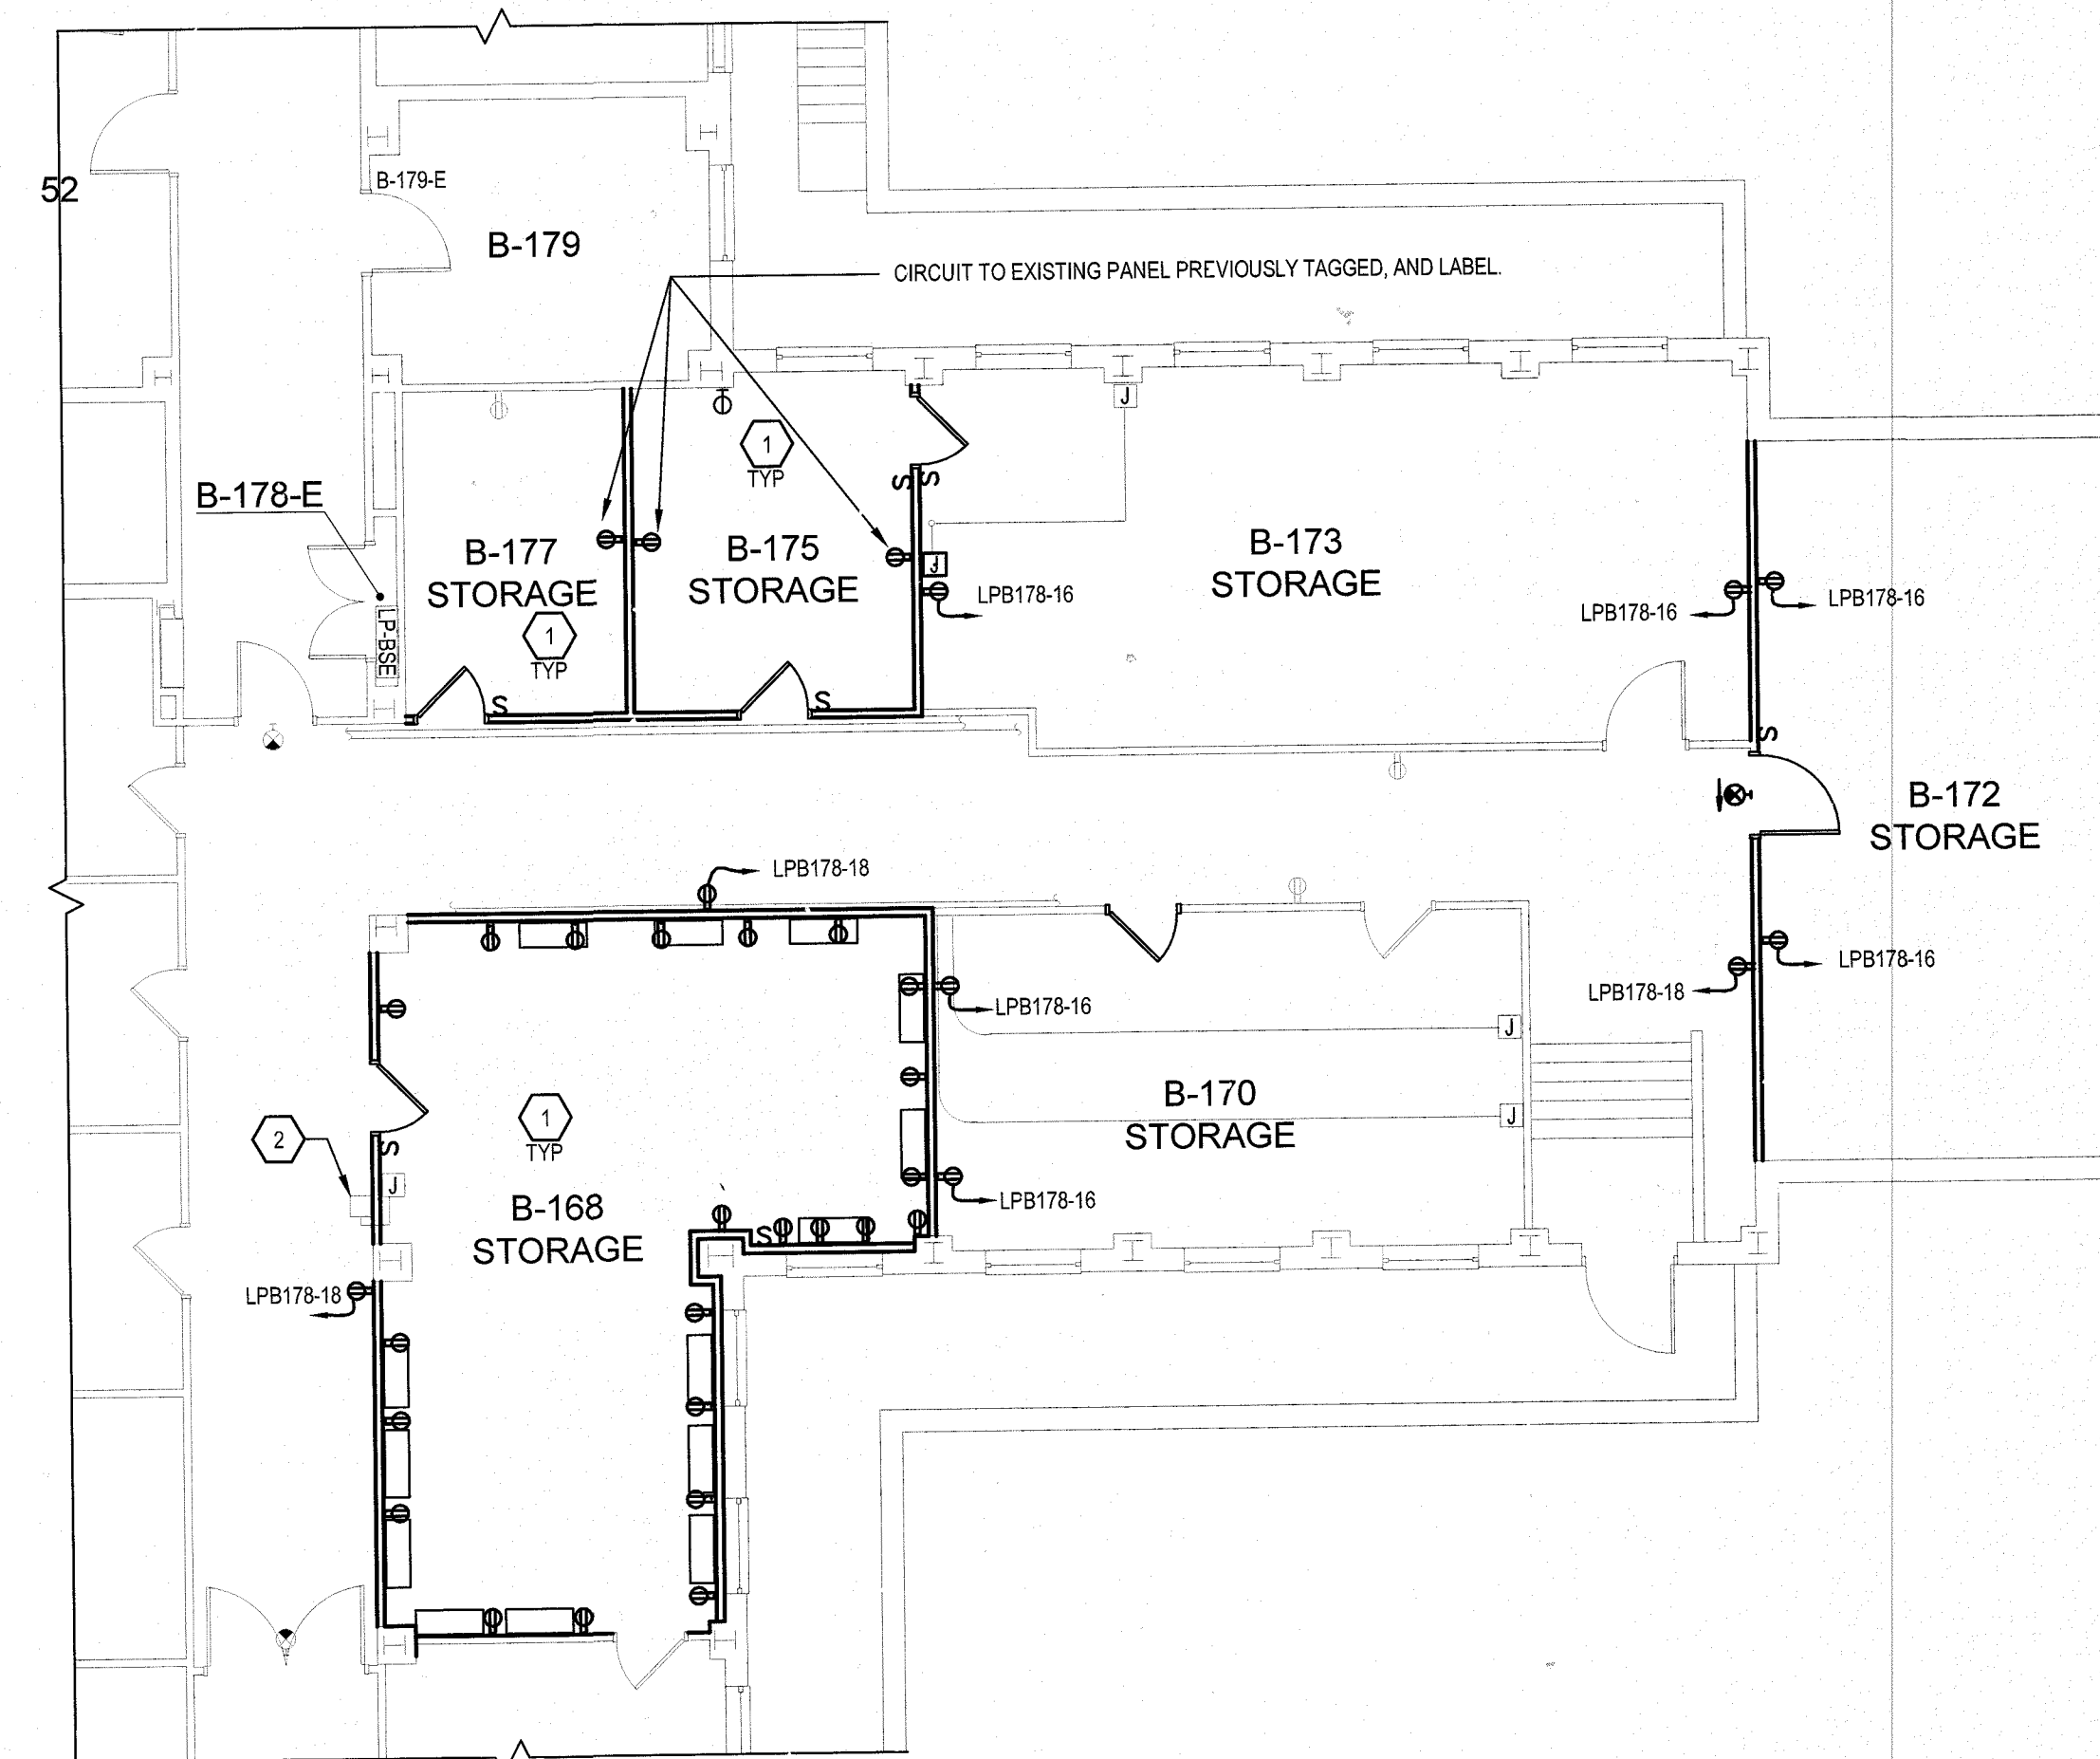


2 PARTIAL BASEMENT FLOOR PLAN
E-101 SCALE: 1/8" = 1'-0"

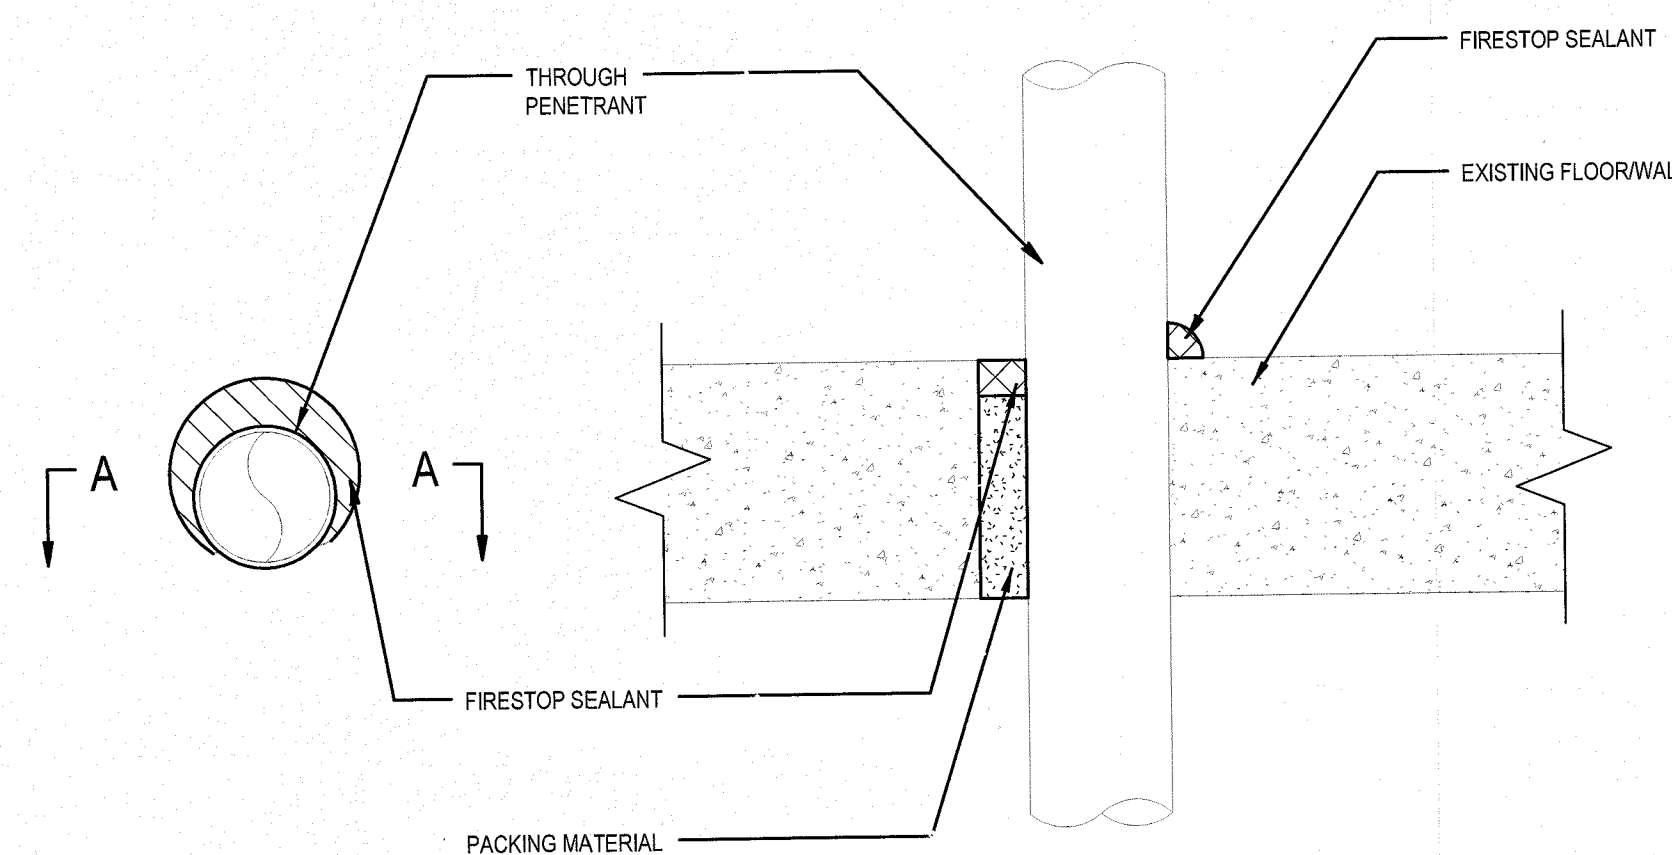


SECTION A-A

3 TYPICAL FIRE STOPPING DETAIL - UNINSULATED PIPE
E-101 SCALE: 3" = 1'-0"

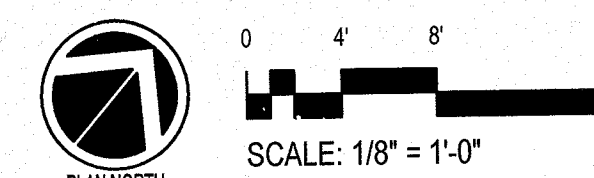

Project Key

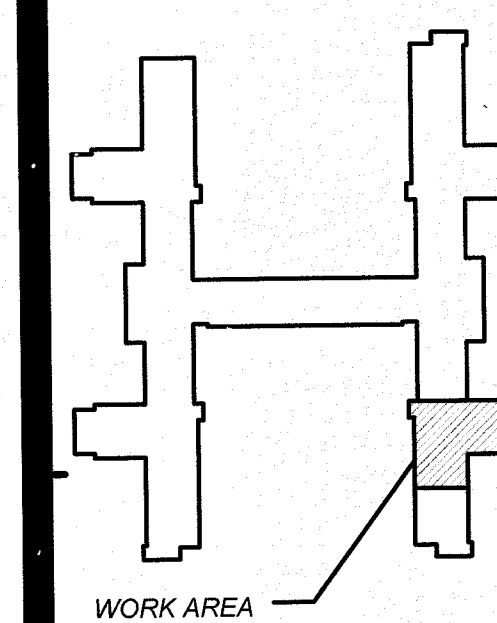

REVISIONS

Rev No	Description	Date

Client

Project Title

B39 ASBESTOS ABATEMENT
CENTRAL NEW YORK PSYCHIATRIC CENTER

Drawing Title

ELECTRICAL REMOVAL AND RENOVATION PLANS

Phase

ISSUED FOR BID

Drawn By: S.M.B. MAH Checked By: MAH Date: 03/16/2018

Seal & Signature DASNY Project No: 34173099999

Drawing Number E-101

Drawing 6 of 8

STATE OF NEW YORK LICENSED PROFESSIONAL ENGINEER