

Consultants:  
**DELTA ENGINEERS, ARCHITECTS & LAND SURVEYORS**  
 860 HOOVER ROAD  
 ENDWELL, NY 13760  
 607-231-6600  
 2016 194 000


**RE** RAVI ENGINEERING & LAND SURVEYING  
 210 SOUTH CLINTON AVE. #1  
 ROCHESTER, NY 14610  
 565-223-3560

PANEL DESIGNATION:		LP-B-178		SERVICE:		120/208V, 3Ø, 4W		
LOCATION:		ELECTRICAL CLOSET B-178-E		MAIN:		100 AMP M.C.B.		
EQUIPMENT/AREA SERVICED	CKT. BRK. AMP	CKT. #	PHASE LOAD VOLT-AMPS			CKT. #	CKT. BRK. AMP	EQUIPMENT/AREA SERVICED
			A	B	C			
LIGHTS B-179	-	1	0000	0000		2	-	LIGHTS CHAPEL
OUTLETS B-155, B-156	-	3		0000	0000	4	-	LIGHTS B-155, B-156, B-157
OUTLETS B-177, B-175	-	5			0000	6	-	LIGHTS EAST HALLWAY
MISC.	-	7	0000	0000		8	-	LIGHTS B-177, B-175, B-173, B-172
MISC.	-	9		0000	0000	10	-	AC
AC	-	11			0000	12	-	AC
AC	-	13	0000	0000		14	-	AC
AC	-	15		0000	0000	16	-	SPARE
AC	-	17			0000	18	-	SPARE
TOTAL PHASE LOAD:			0	0	0	0 / (1.73 X 208V)		
TOTAL PANEL LOAD:			0			PANEL AMPS = 0.00		

**1 EXISTING PANEL**  
 E-601 SCALE: NTS

PANEL DESIGNATION:		LP-B-178		SERVICE:		120/208V, 3Ø, 4W		
LOCATION:		ELECTRICAL CLOSET B-178-E		MAIN:		100 AMP M.C.B.		
EQUIPMENT/AREA SERVICED	CKT. BRK. AMP	CKT. #	PHASE LOAD VOLT-AMPS			CKT. #	CKT. BRK. AMP	EQUIPMENT/AREA SERVICED
			A	B	C			
LIGHTS B-179	-	1	0000	0000		2	-	LIGHTS CHAPEL
OUTLETS B-155, B-156	-	3		0000	0000	4	-	LIGHTS B-155, B-156, B-157
OUTLETS B-177, B-175	-	5			0000	6	-	LIGHTS EAST HALLWAY
MISC.	-	7	0000	0000		8	-	LIGHTS B-177, B-175, B-173, B-172
MISC.	-	9		0000	0000	10	-	AC
AC	-	11			0000	12	-	AC
AC	-	13	0000	0000		14	-	AC
AC	-	15		0000	1080	16	20	RECEPTS. B-172, B-173, B-175
AC	-	17			0000	18	20	RECEPTS. HALL BY B-168, B-172
TOTAL PHASE LOAD:						/ (1.73 X 208V)		
TOTAL PANEL LOAD:						PANEL AMPS =		

**2 PROPOSED PANEL**  
 E-601 SCALE: NTS

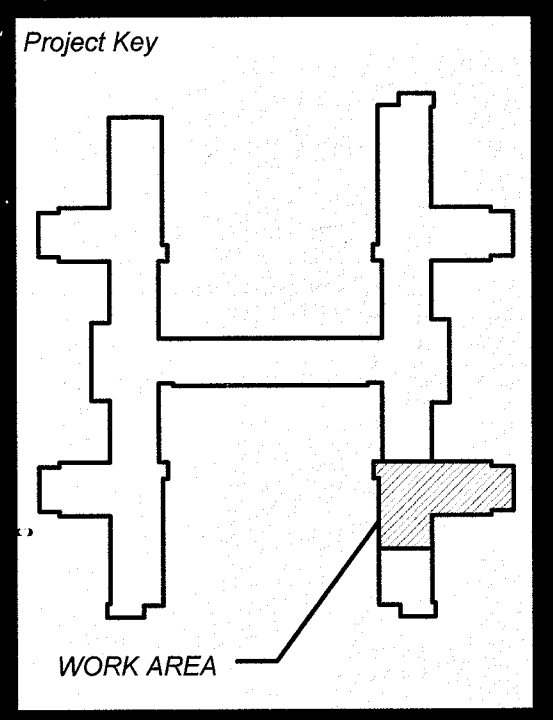

REVISIONS

Rev. No.	Description	Date:

Client  
**NEW YORK STATE OF OPPORTUNITY** **Office of Mental Health**

Project Title  
 B39 ASBESTOS ABATEMENT  
 CENTRAL NEW YORK PSYCHIATRIC CENTER

Drawing Title  
 PANEL SCHEDULE

Phase  
 ISSUED FOR BID

Drawn By: **S.M.B** | Checked By: **MAH** | Date: **03/16/2018**

Seal & Signature  

 DASNY Project No: 34173099999  
 Drawing Number: **E-601**  
 Drawing 8 of 8