


**KEYED NOTES:**


- 1 PROVIDE THROUGH AND MEMBRANE FIRESTOPPING AT ALL PENETRATIONS THROUGH FIRE RATED CONSTRUCTION. REFER TO ARCHITECTURAL PLANS FOR LOCATIONS OF FIRE RATED CONSTRUCTION. REFER TO SPECIFICATION SECTION 078400 FOR ADDITIONAL FIRESTOPPING REQUIREMENTS.

**GENERAL NOTES:**


- 1. EXISTING SPRINKLER PIPING AND SPRINKLER HEADS TO REMAIN.
- 2. EXISTING STEAM/CONDENSATE, DOMESTIC, SANITARY, AND VENT PIPING TO REMAIN UNLESS OTHERWISE NOTED. REINSULATE EXISTING PIPING.
- 3. EXISTING RADIATORS TO REMAIN
- 4. VERIFY ALL PIPE AND INSULATION SIZES IN FIELD.

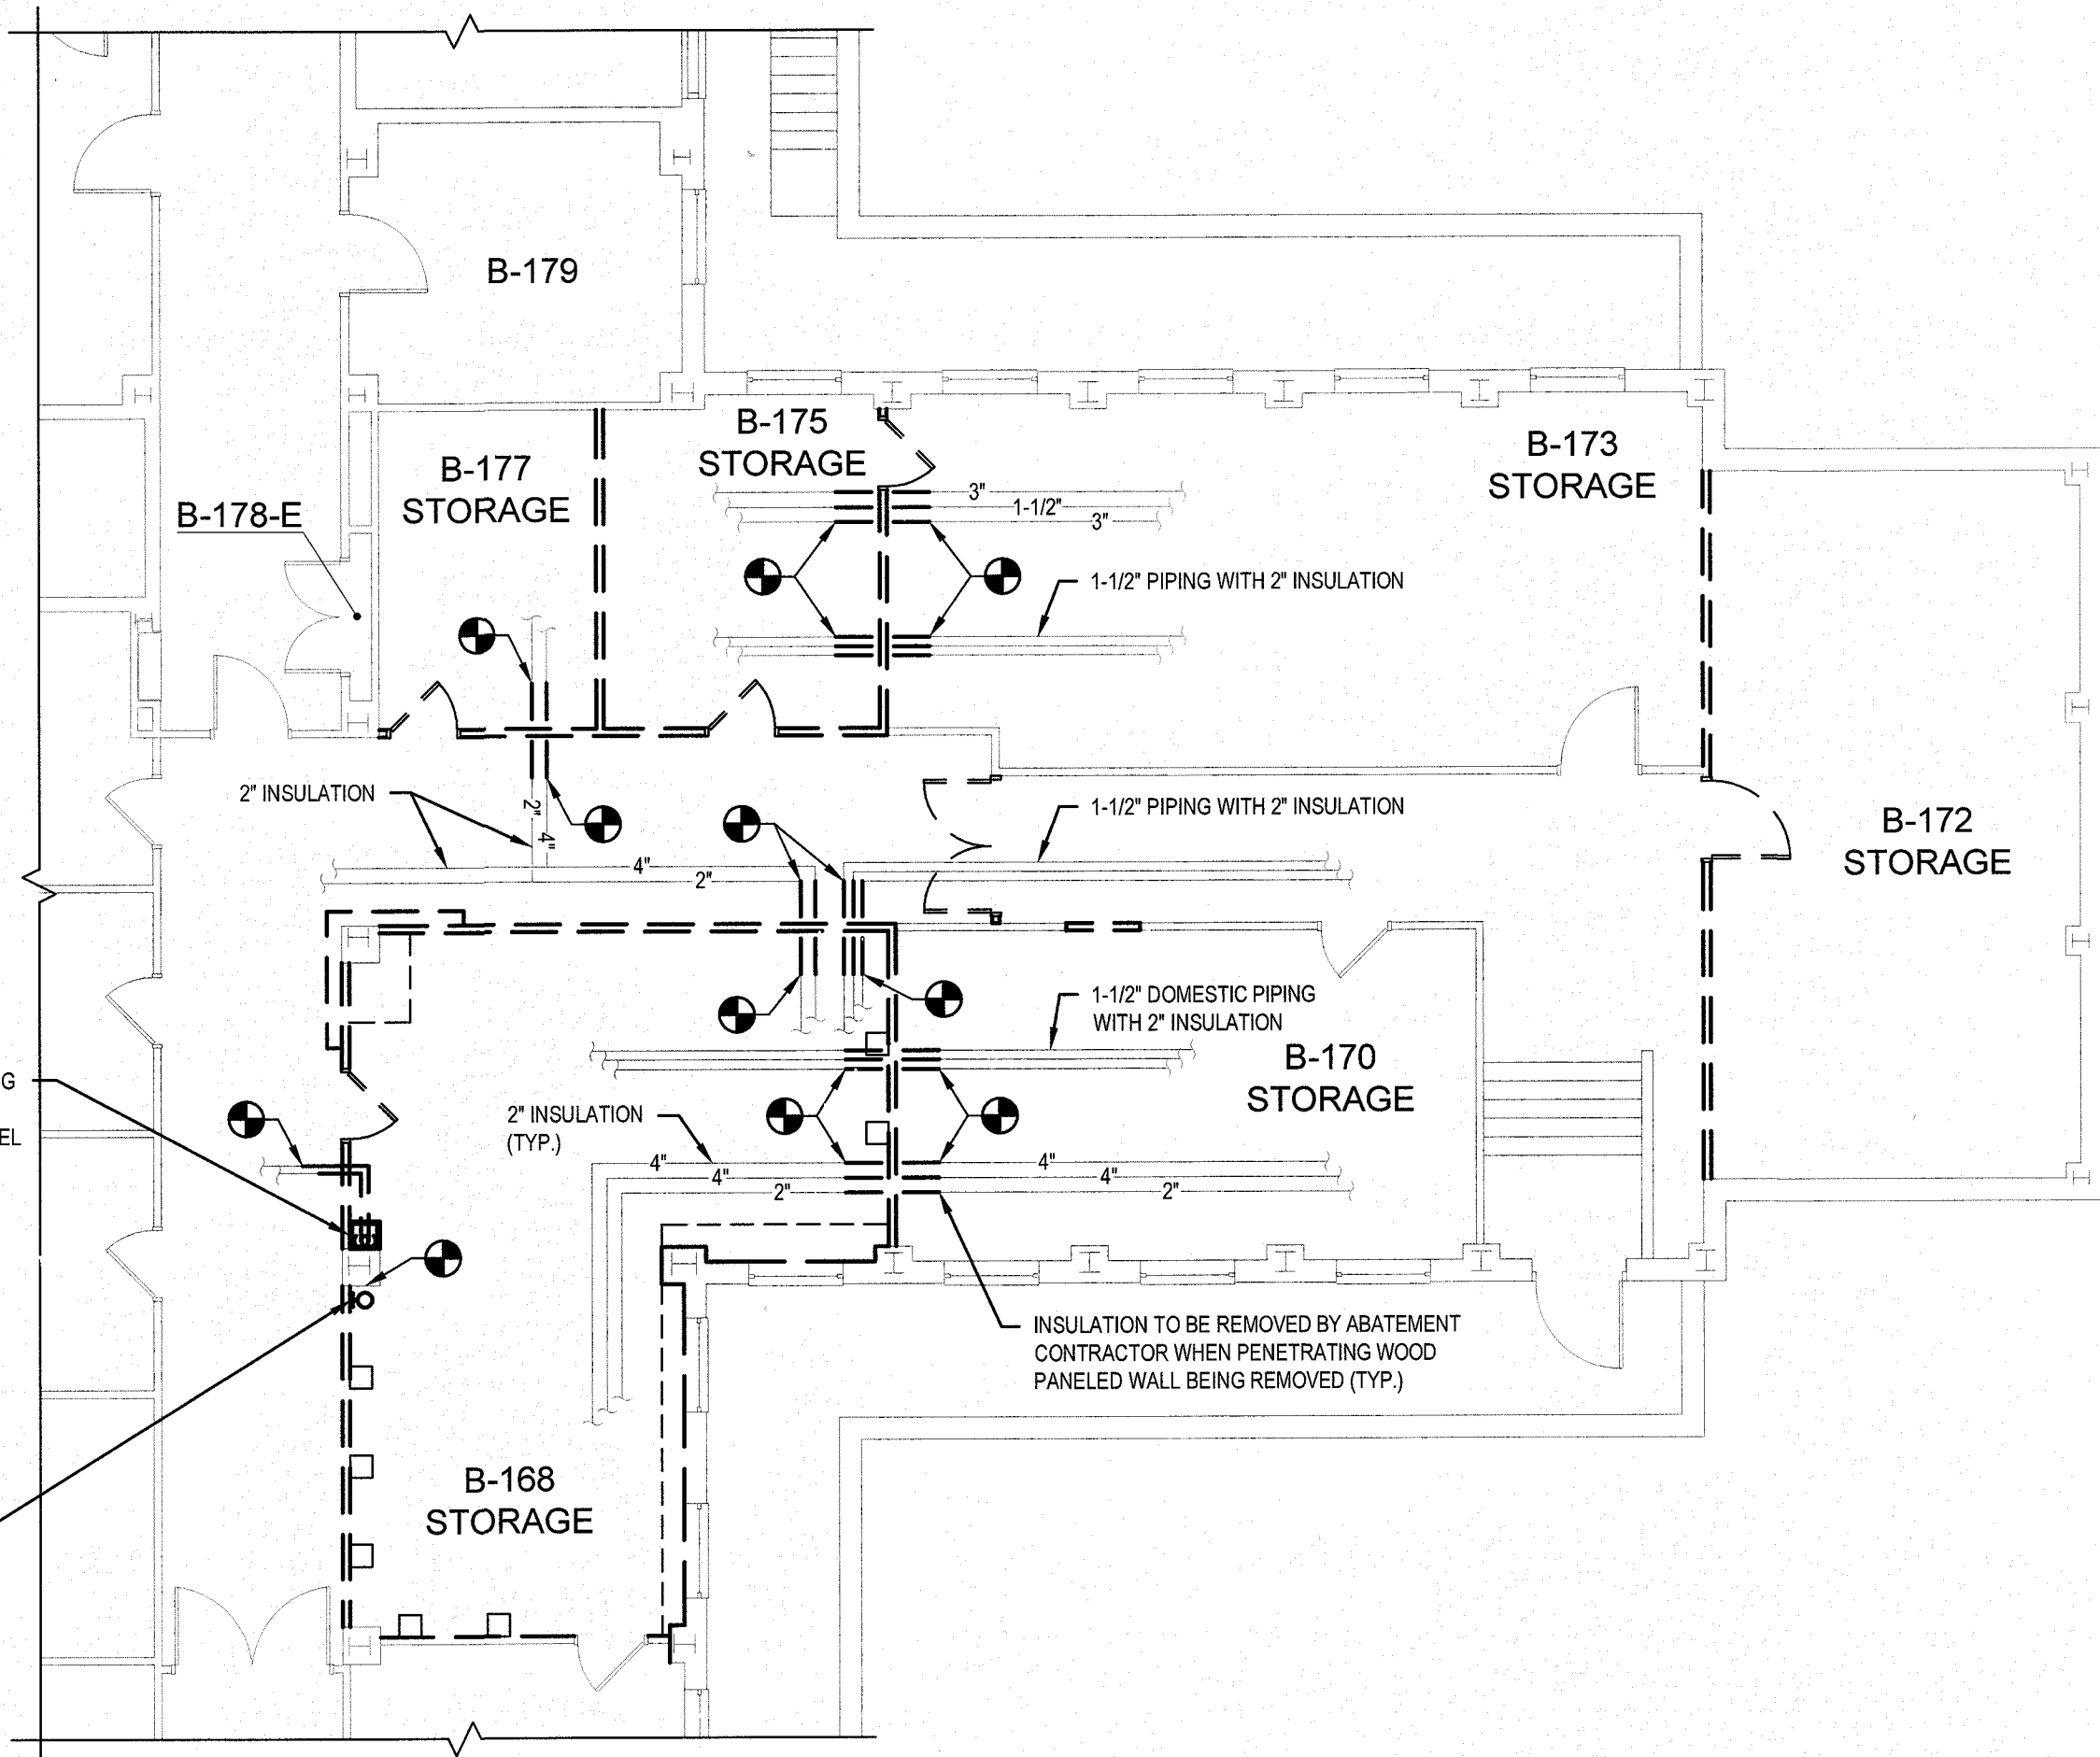

**1 BASEMENT PLUMBING REMOVAL PLAN**  
 P-101 SCALE: 1/8" = 1'-0"

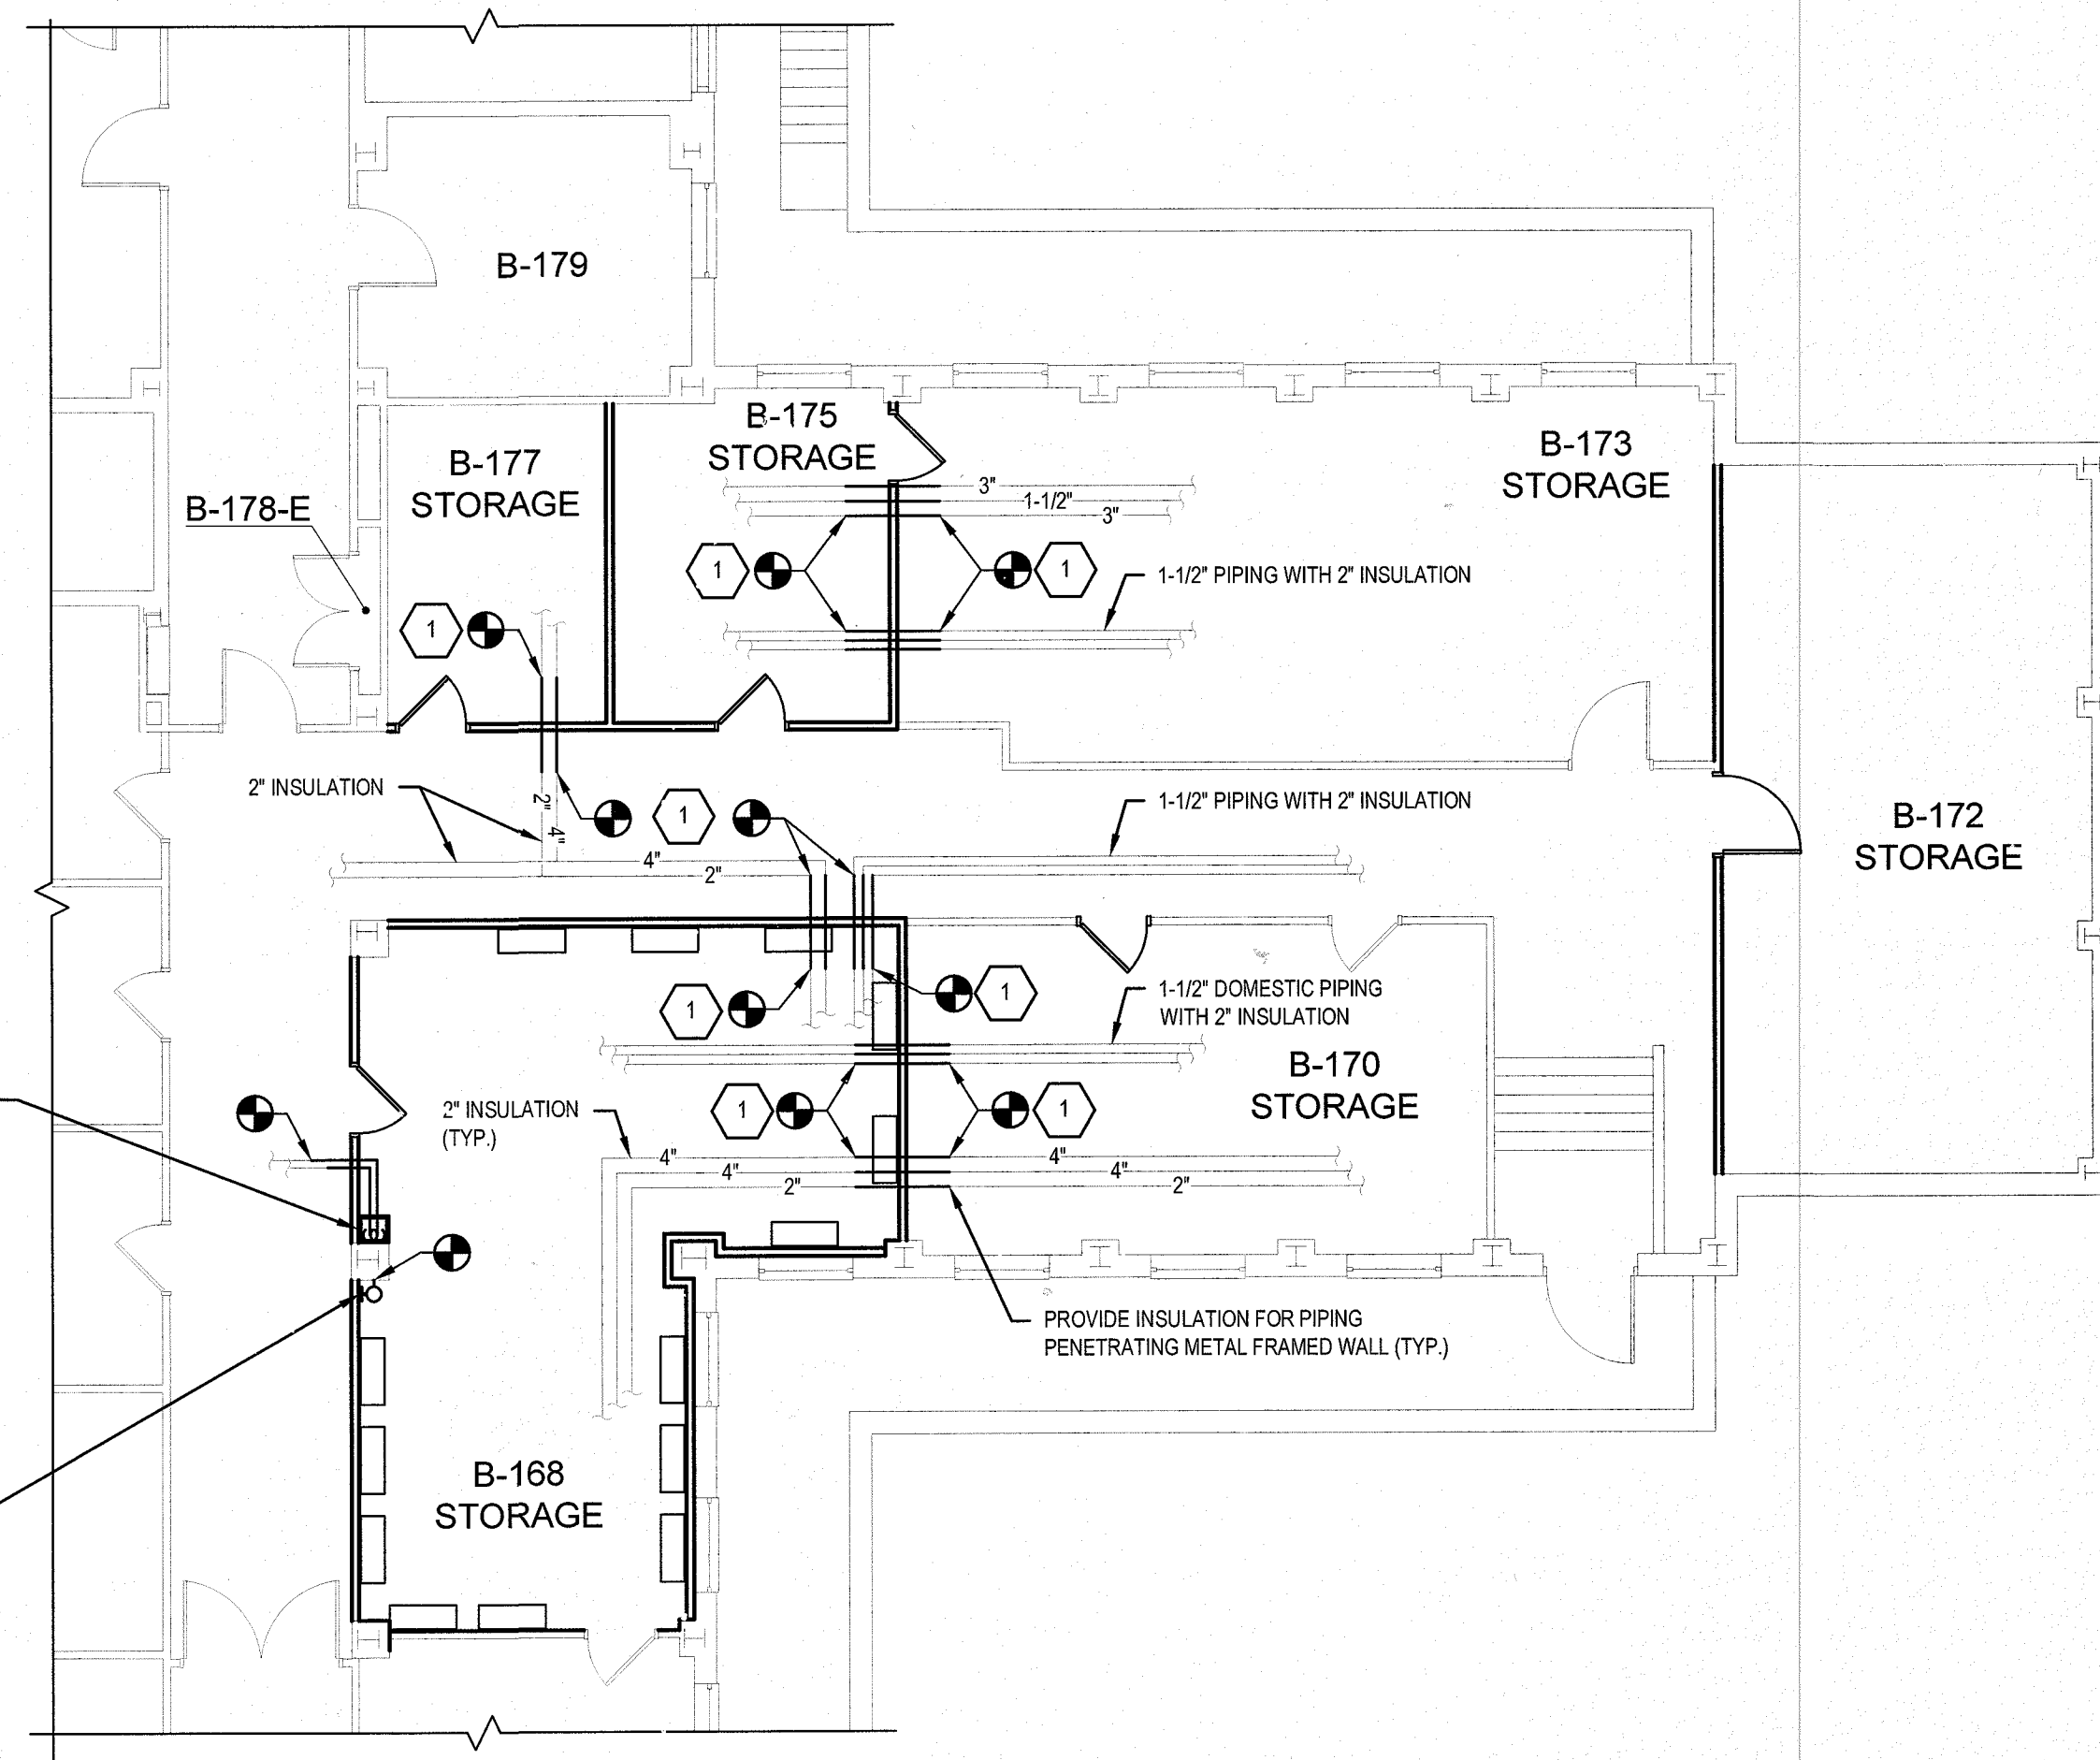


**2 BASEMENT PLUMBING RENOVATION PLAN**  
 P-101 SCALE: 1/8" = 1'-0"

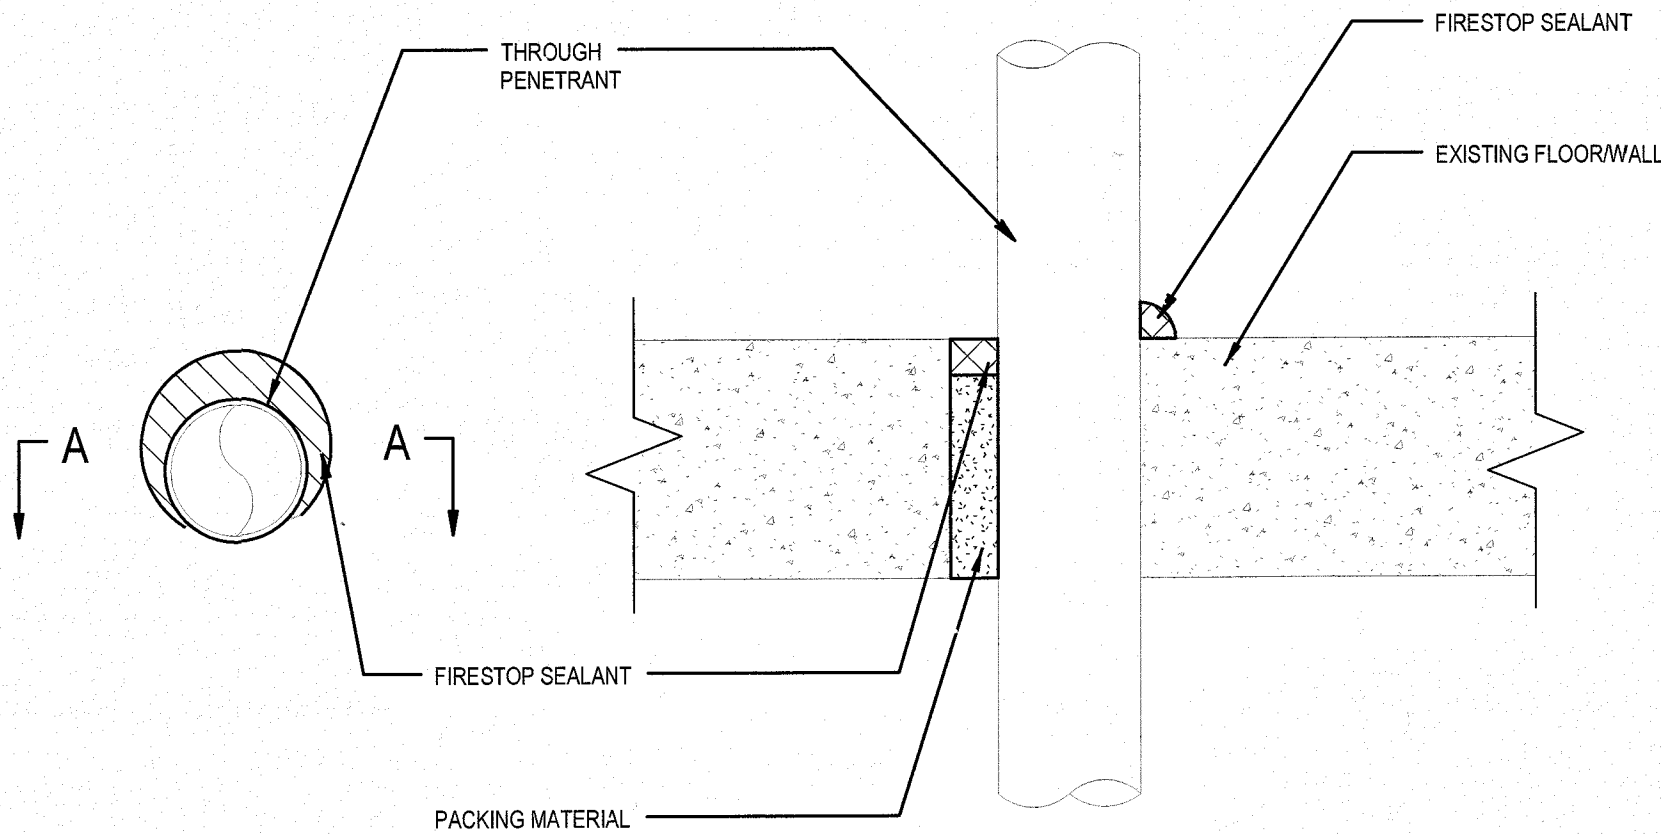

SECTION A-A

**3 TYPICAL FIRESTOPPING DETAIL - UNINSULATED PIPE**  
 P-101 SCALE: 1/8" = 1'-0"

UL SYSTEM No.: C-AJ-1149  
 F RATING - 2 HR

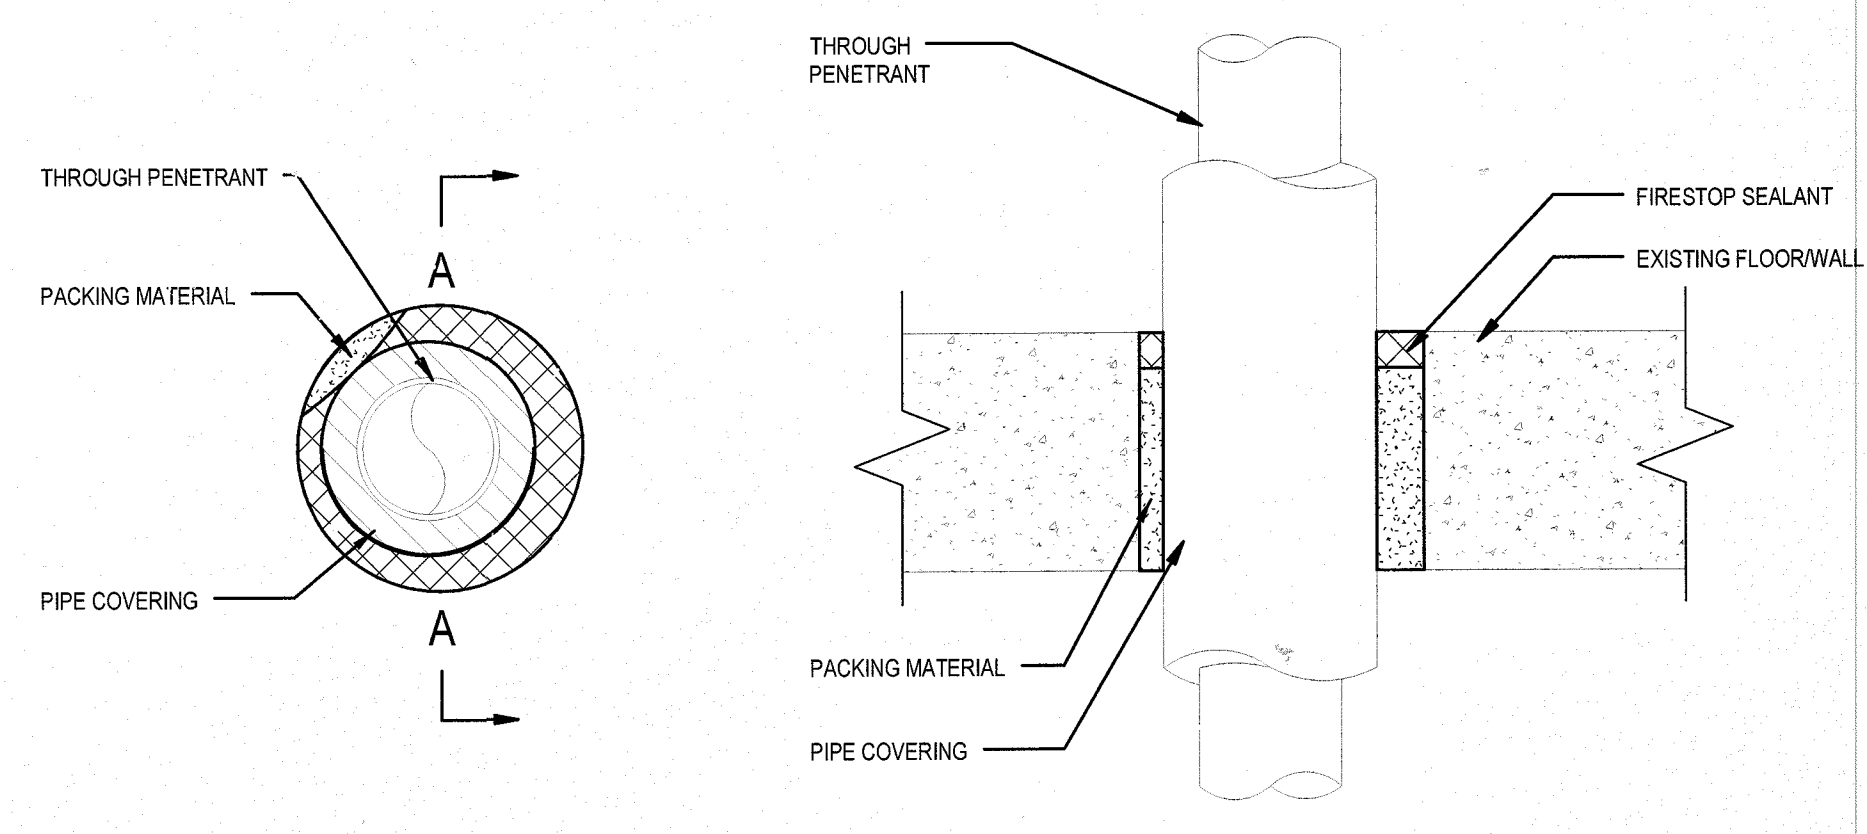


SECTION A-A

**4 TYPICAL FIRESTOPPING DETAIL - INSULATED PIPE**  
 P-101 SCALE: 1/8" = 1'-0"

UL SYSTEM No.: C-AJ-5305  
 F RATING - 2 HR


**Project Key**

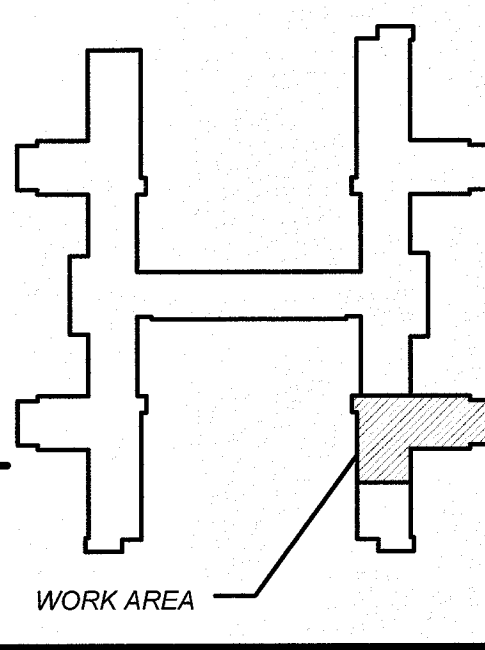

**REVISIONS**

Rev No	Description	Date

**Client**

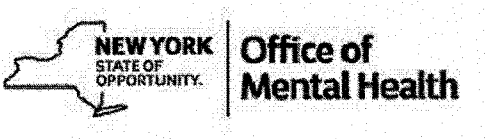

Project Title  
**B39 ASBESTOS ABATEMENT**  
 CENTRAL NEW YORK  
 PSYCHIATRIC CENTER

**Drawing Title**


**PLUMBING REMOVAL AND RENOVATION PLANS**

**Phase**

ISSUED FOR BID

Drawn By: **DK** Checked By: **MAH** Date: **03/16/2018**

Seal & Signature:  DASNY Project No: 34173099999

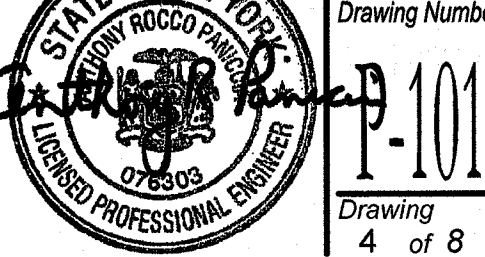

Drawing No: **P-101**  
 Drawing 4 of 8

